


Legend Ventilation Plan Basement

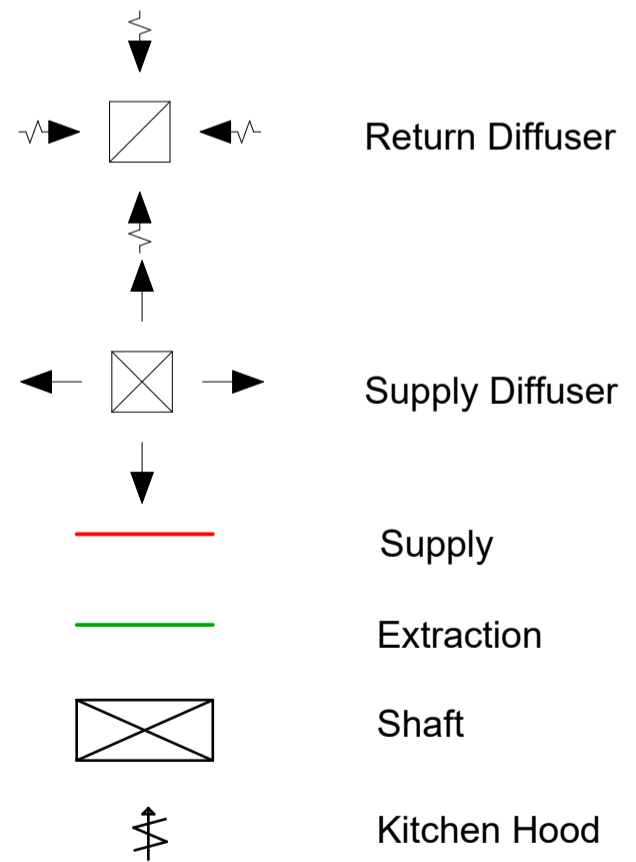



Ventilation ducts with a diameter of 80 mm.



 





Bring ideas to life
VIA University College

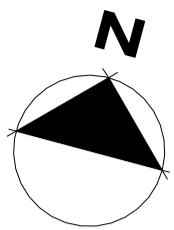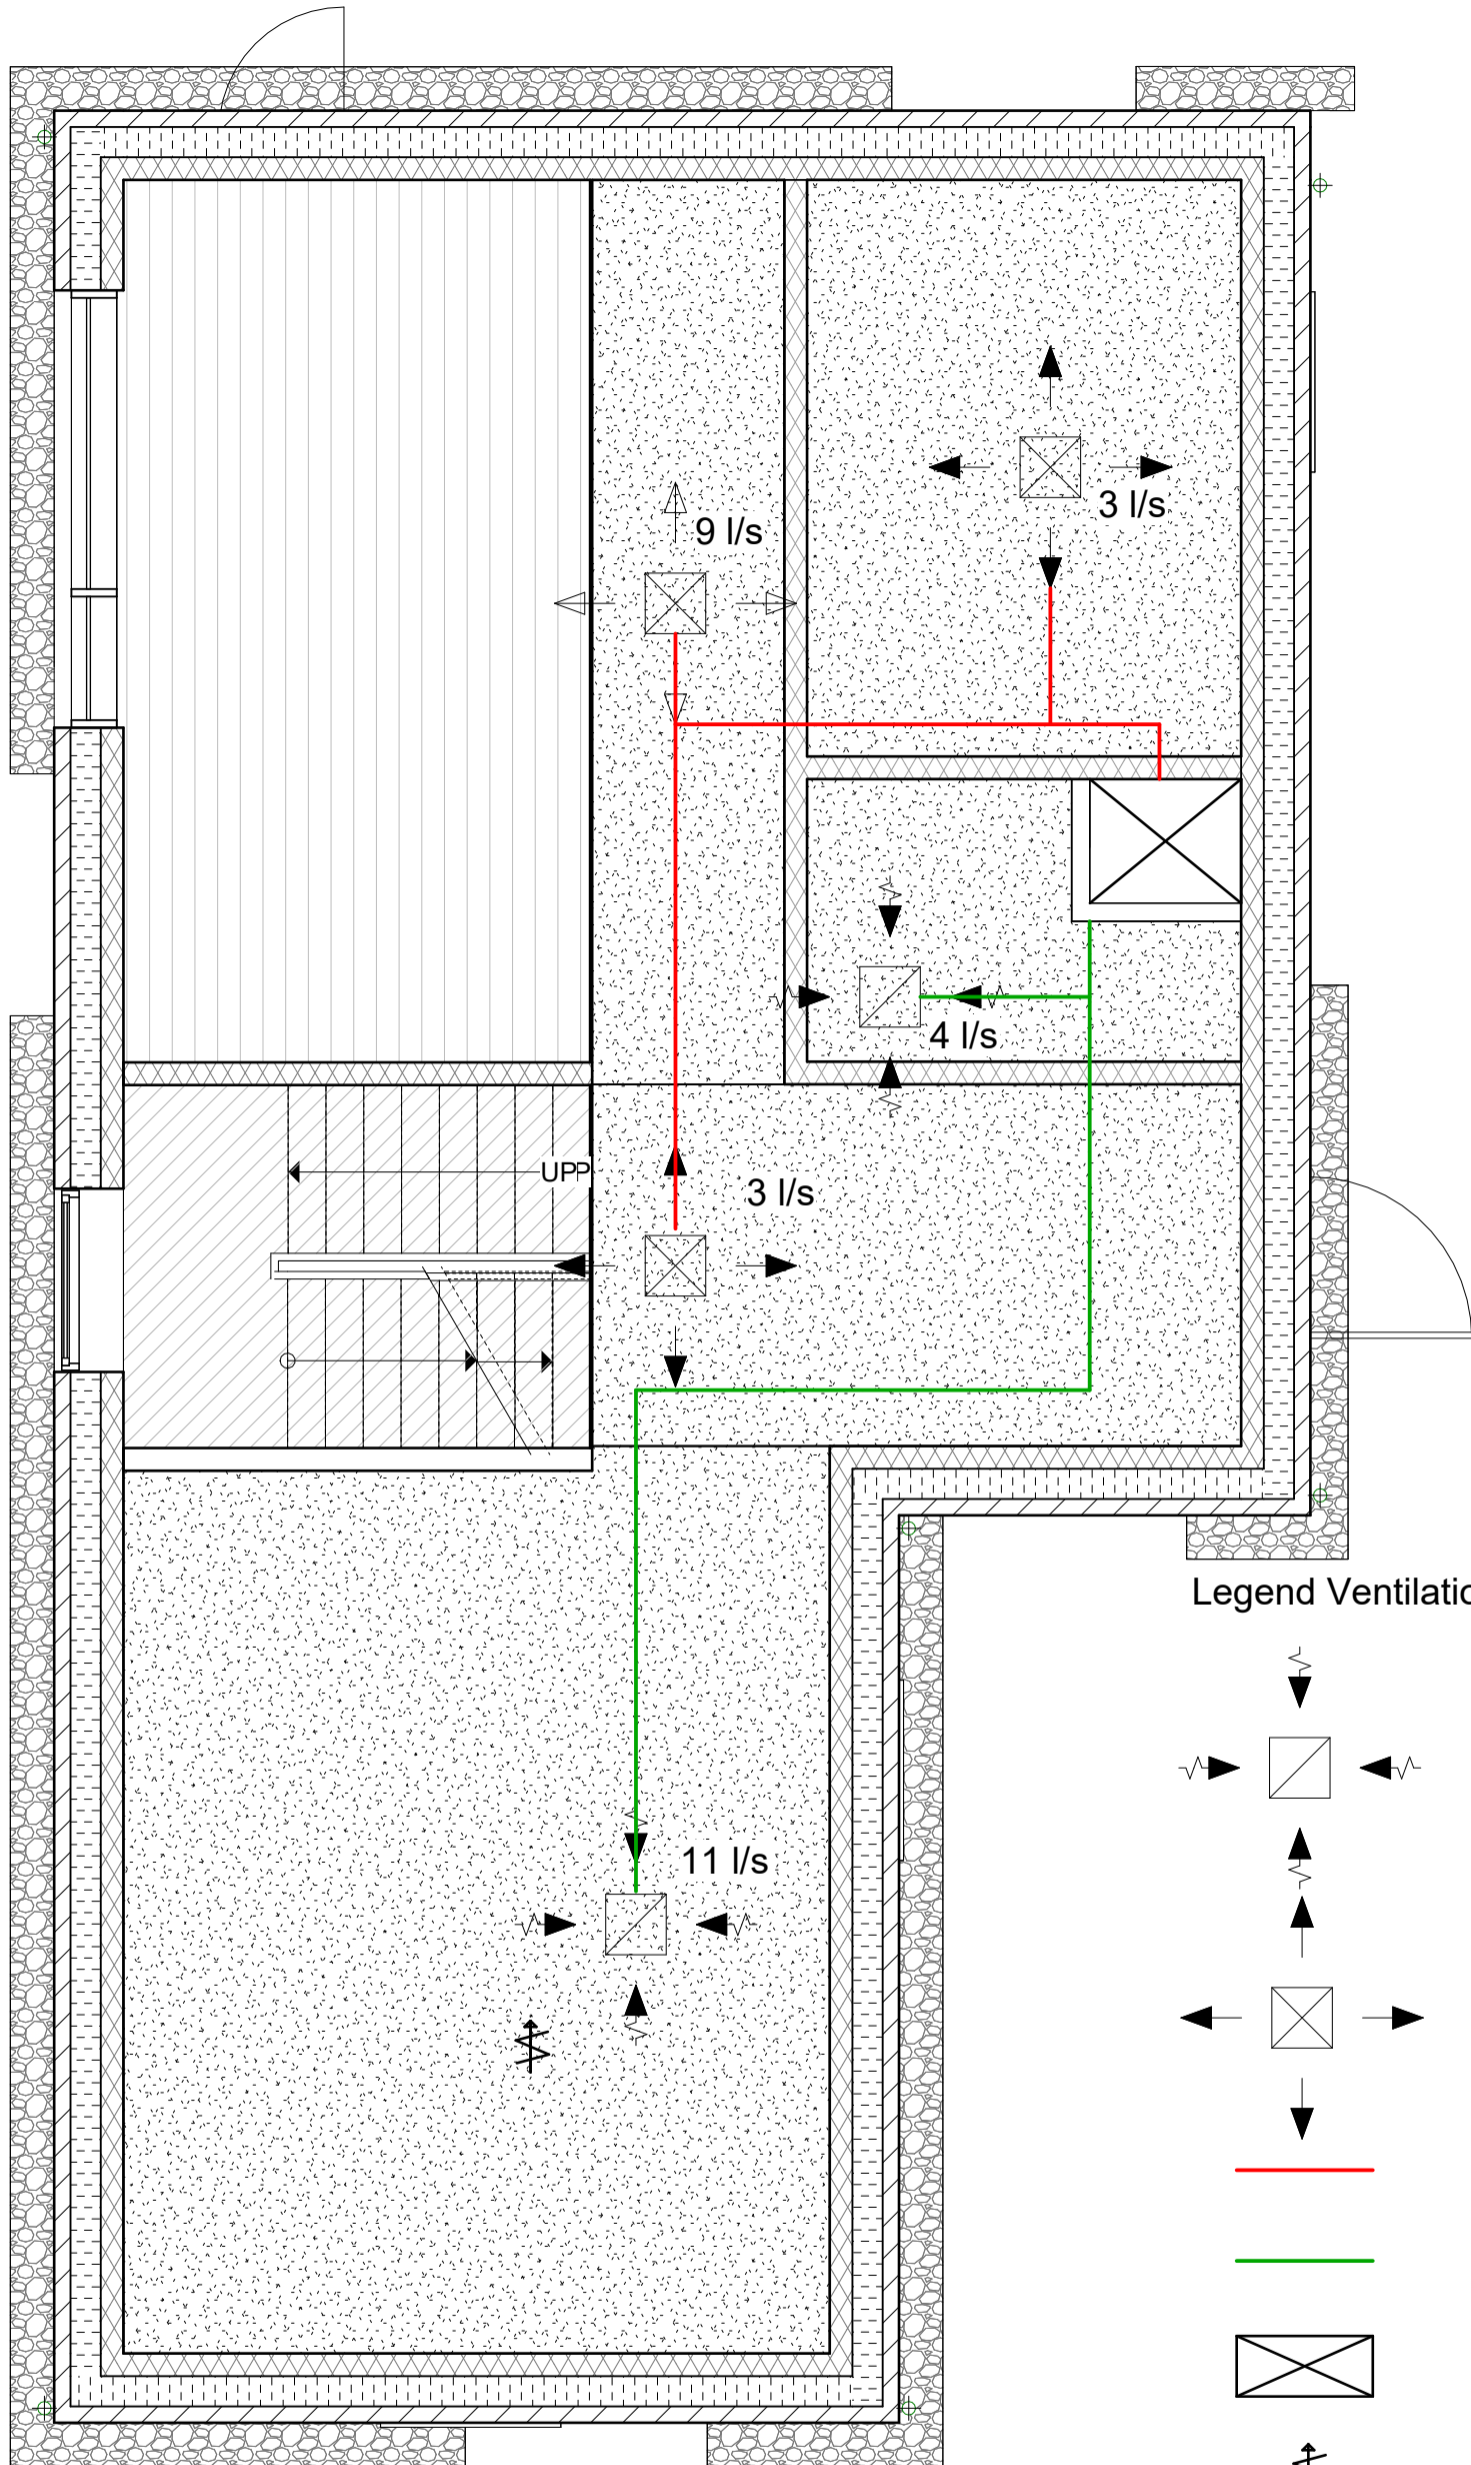VIA Built Environment & Engineering
Campus Horsens

PROJECT: 2 storey house with basement	DATE: 12/13/22	IXX_K01_TXX_H1_EX_N28
SUBJECT: Ventilation Plan Groundfloor	SCALE: 1 : 50	
DRAWN BY: Dimitrian Cebotaru	CLASS: AH21-22S	



Legend Ventilation Plan Basement

-  Return Diffuser
-  Supply Diffuser
-  Supply
-  Extraction
-  Shaft
-  Kitchen Hood


Ventilation ducts with a diameter of 80 mm.



Bring ideas to life
VIA University College

VIA Built Environment & Engineering
Campus Horsens

PROJECT: 2 storey house with basement	DATE: 12/13/22	IXX_K01_TXX_H1_EX_N28
SUBJECT: Ventilation Plan Groundfloor	SCALE: 1 : 50	
DRAWN BY: Dimitrian Cebotaru	CLASS: AH21-22S	

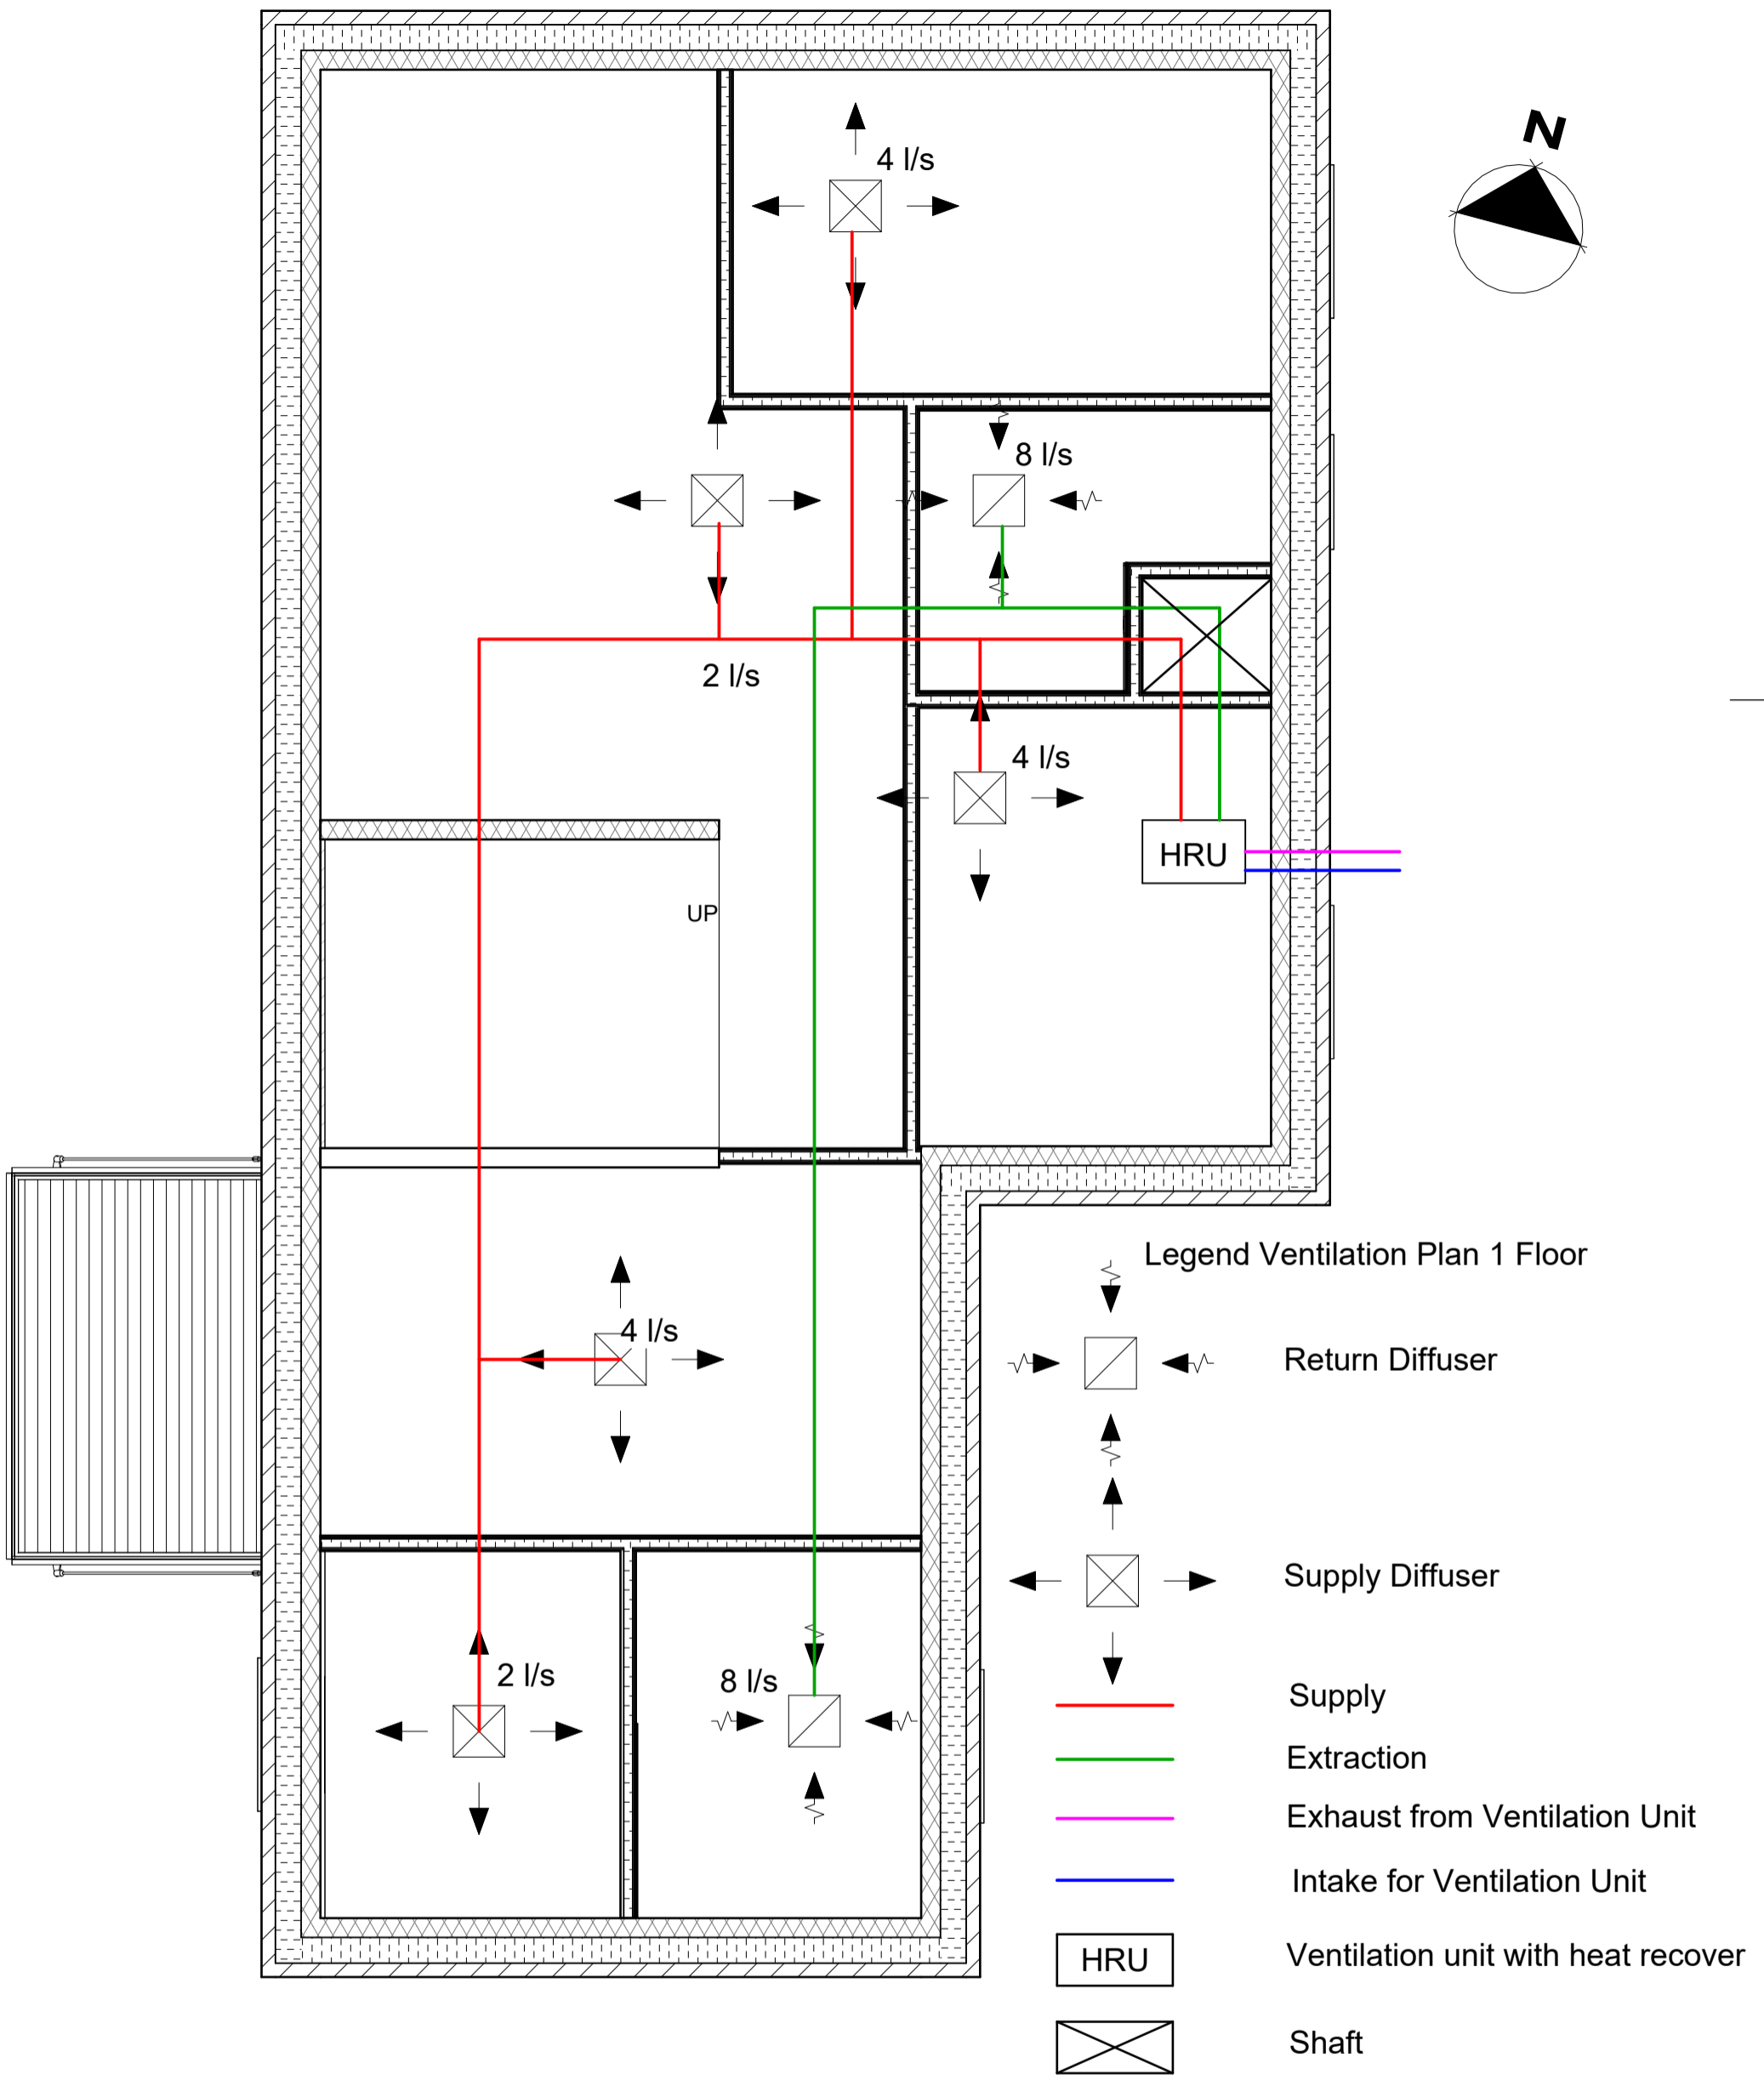

Ventilation ducts with a diameter of 80 mm.



Bring ideas to life
VIA University College

VIA Built Environment & Engineering
Campus Horsens

PROJECT: 2 storey house with basement	DATE: 12/13/22	IXX_K01_TXX_H1_EX_N29
SUBJECT: Ventilation Plan 1 Floor	SCALE: 1 : 50	
DRAWN BY: Dimitrian Cebotaru	CLASS: AH21-22S	