


Legend Water Heating Plan Basement



- Hot Water
- Cold Water
- - - - Return Water
- r1..r4 Radiators
- M Manifold
- Boiler Water Heater
- ⊠ Shaft

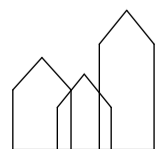

Bring ideas to life
VIA University College

VIA Built Environment & Engineering
Campus Horsens

PROJECT: 2 storey house with basement	DATE: 12/12/22	IXX_K01_TXX_H1_EX_N24
SUBJECT: Water and Heating Plan Basement	SCALE: 1 : 50	
DRAWN BY: Dimitrian Cebotaru	CLASS: AH21-22S	

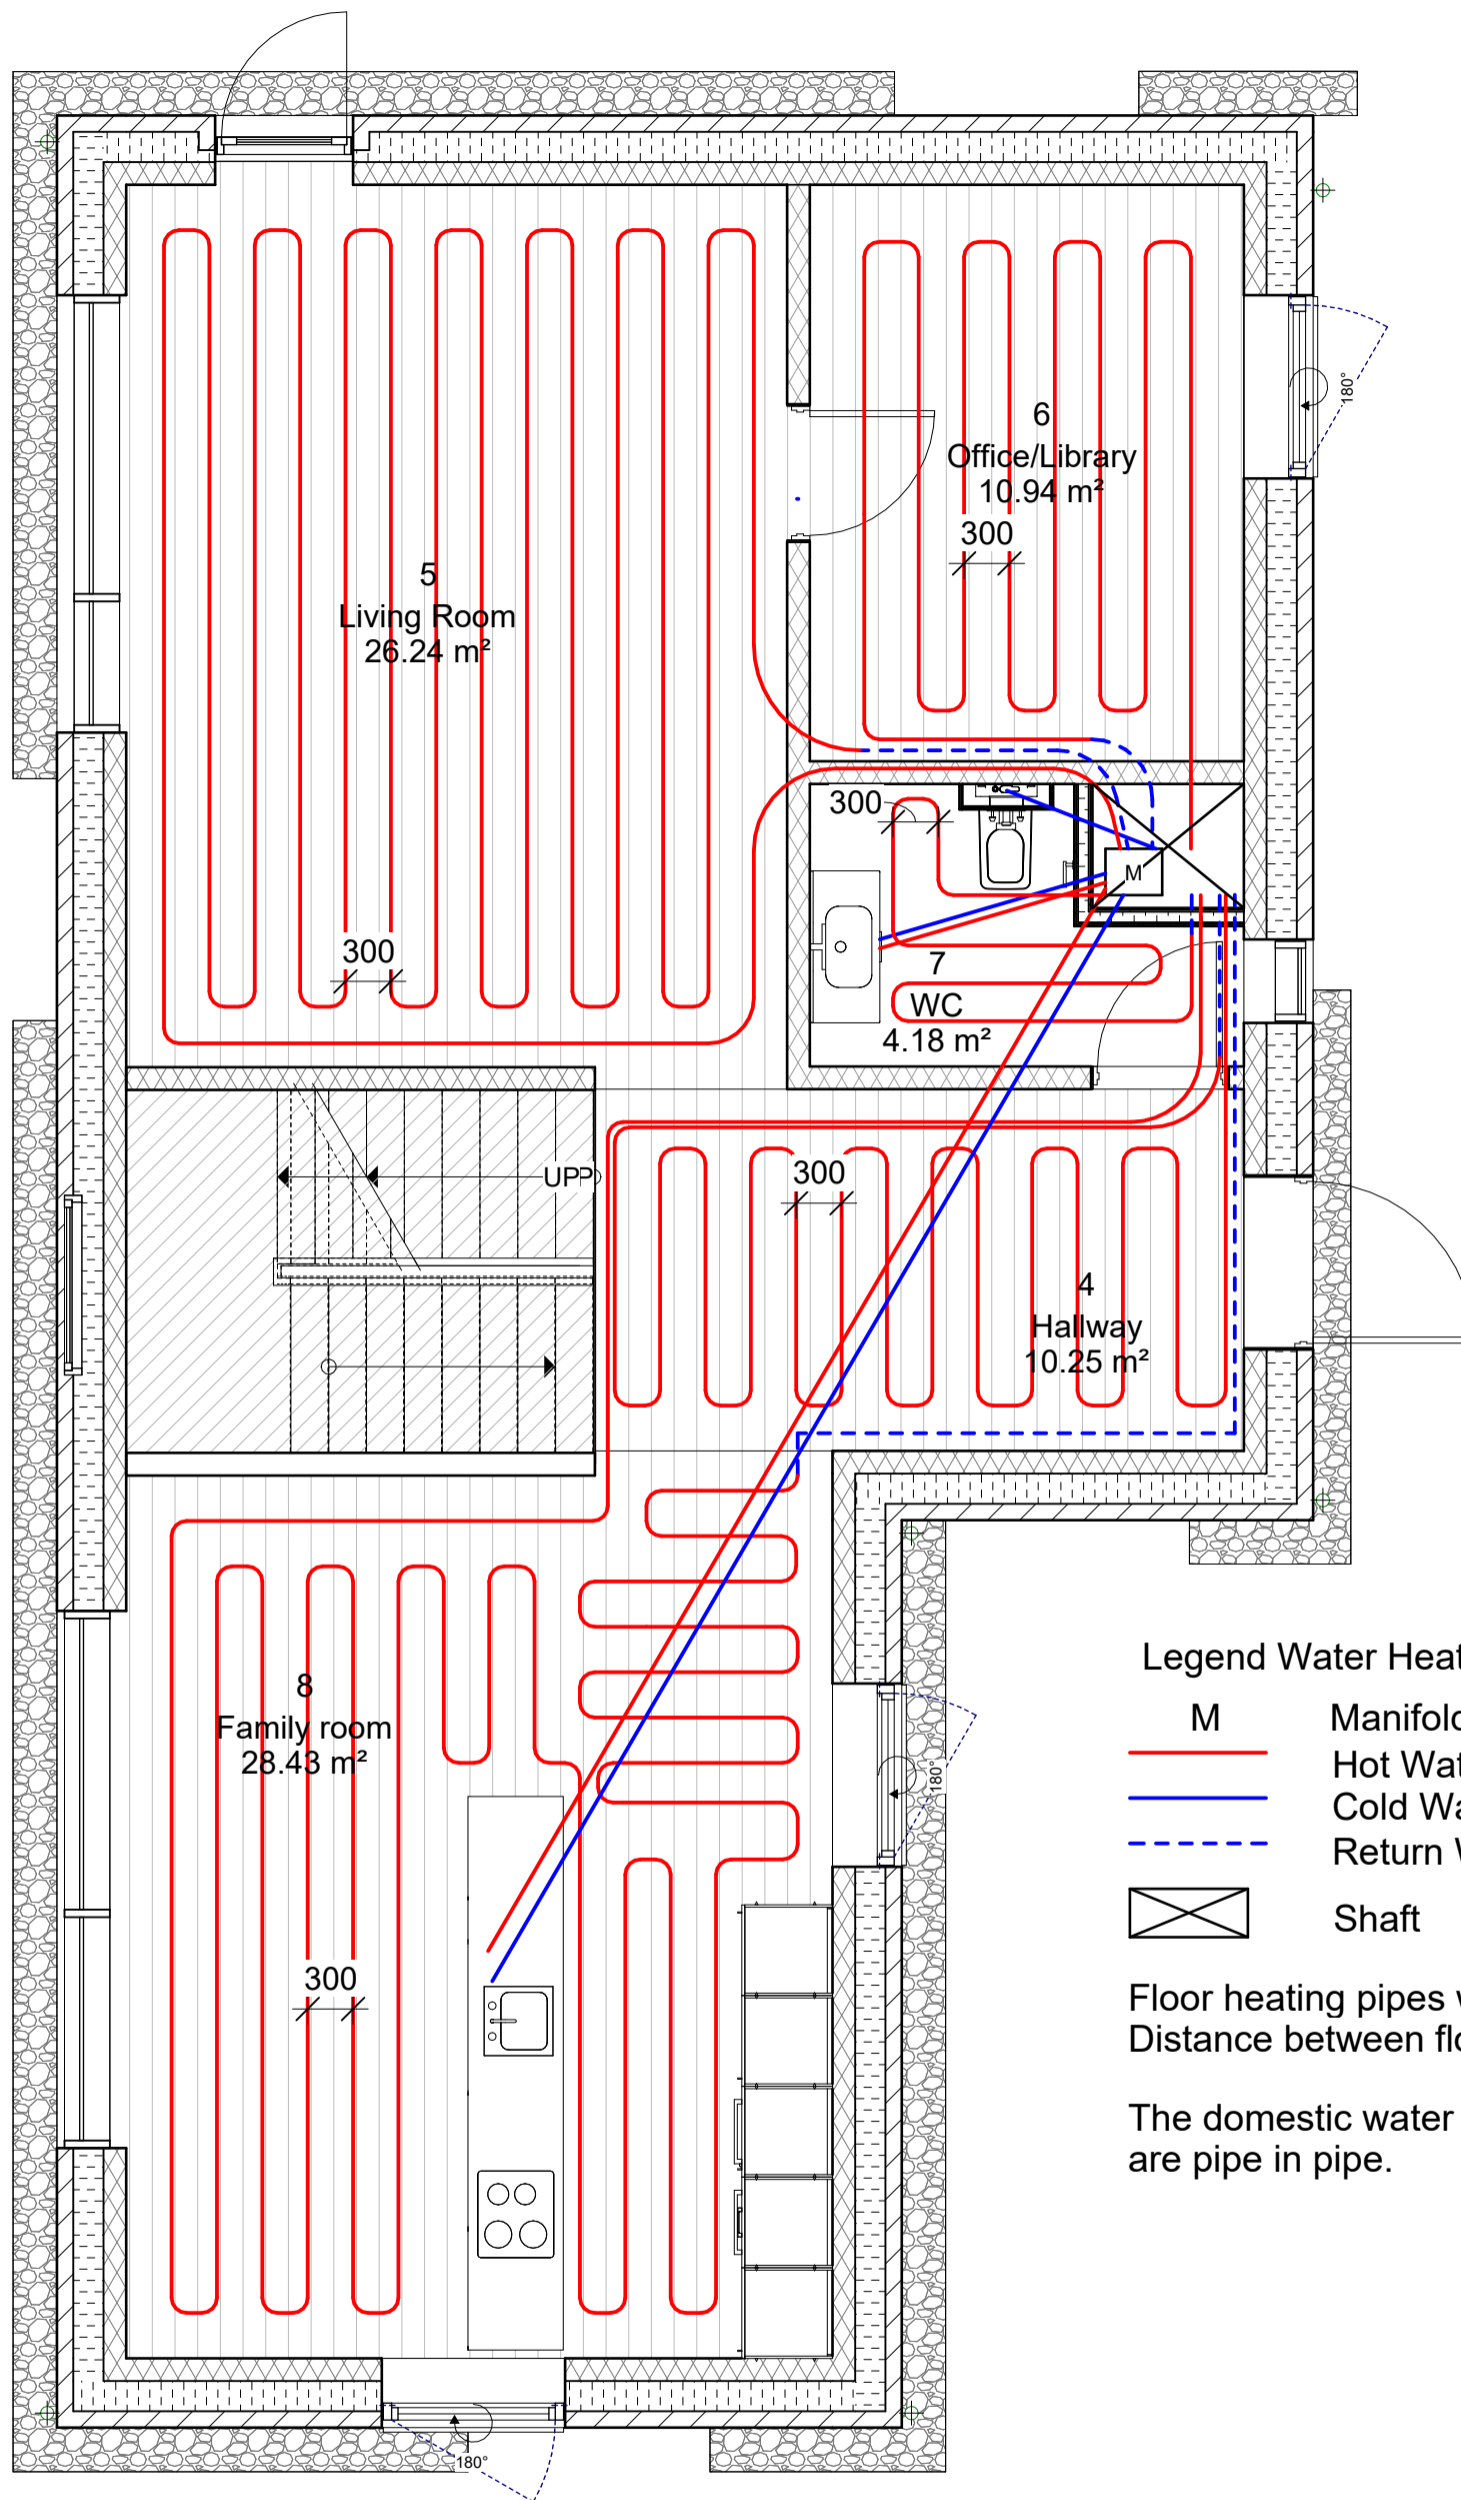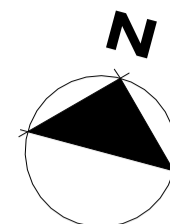


Legend Water Heating Plan GroundFloor

- M Manifold
- Hot Water
- Cold Water
- - - Return Water
- ⊠ Shaft

Floor heating pipes with a diameter of 20mm.
Distance between floor heating pipes is 300 mm.


The domestic water pipes insulated and they are pipe in pipe.

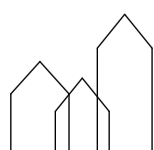

Bring ideas to life
VIA University College

VIA Built Environment & Engineering
Campus Horsens

PROJECT: 2 storey house with basement	DATE: 12/12/22	IXX_K01_TXX_H1_EX_N25
SUBJECT: Water and Heating Plan Groundfloor	SCALE: 1 : 50	
DRAWN BY: Dimtrian Cebotaru	CLASS: AH21-22S	

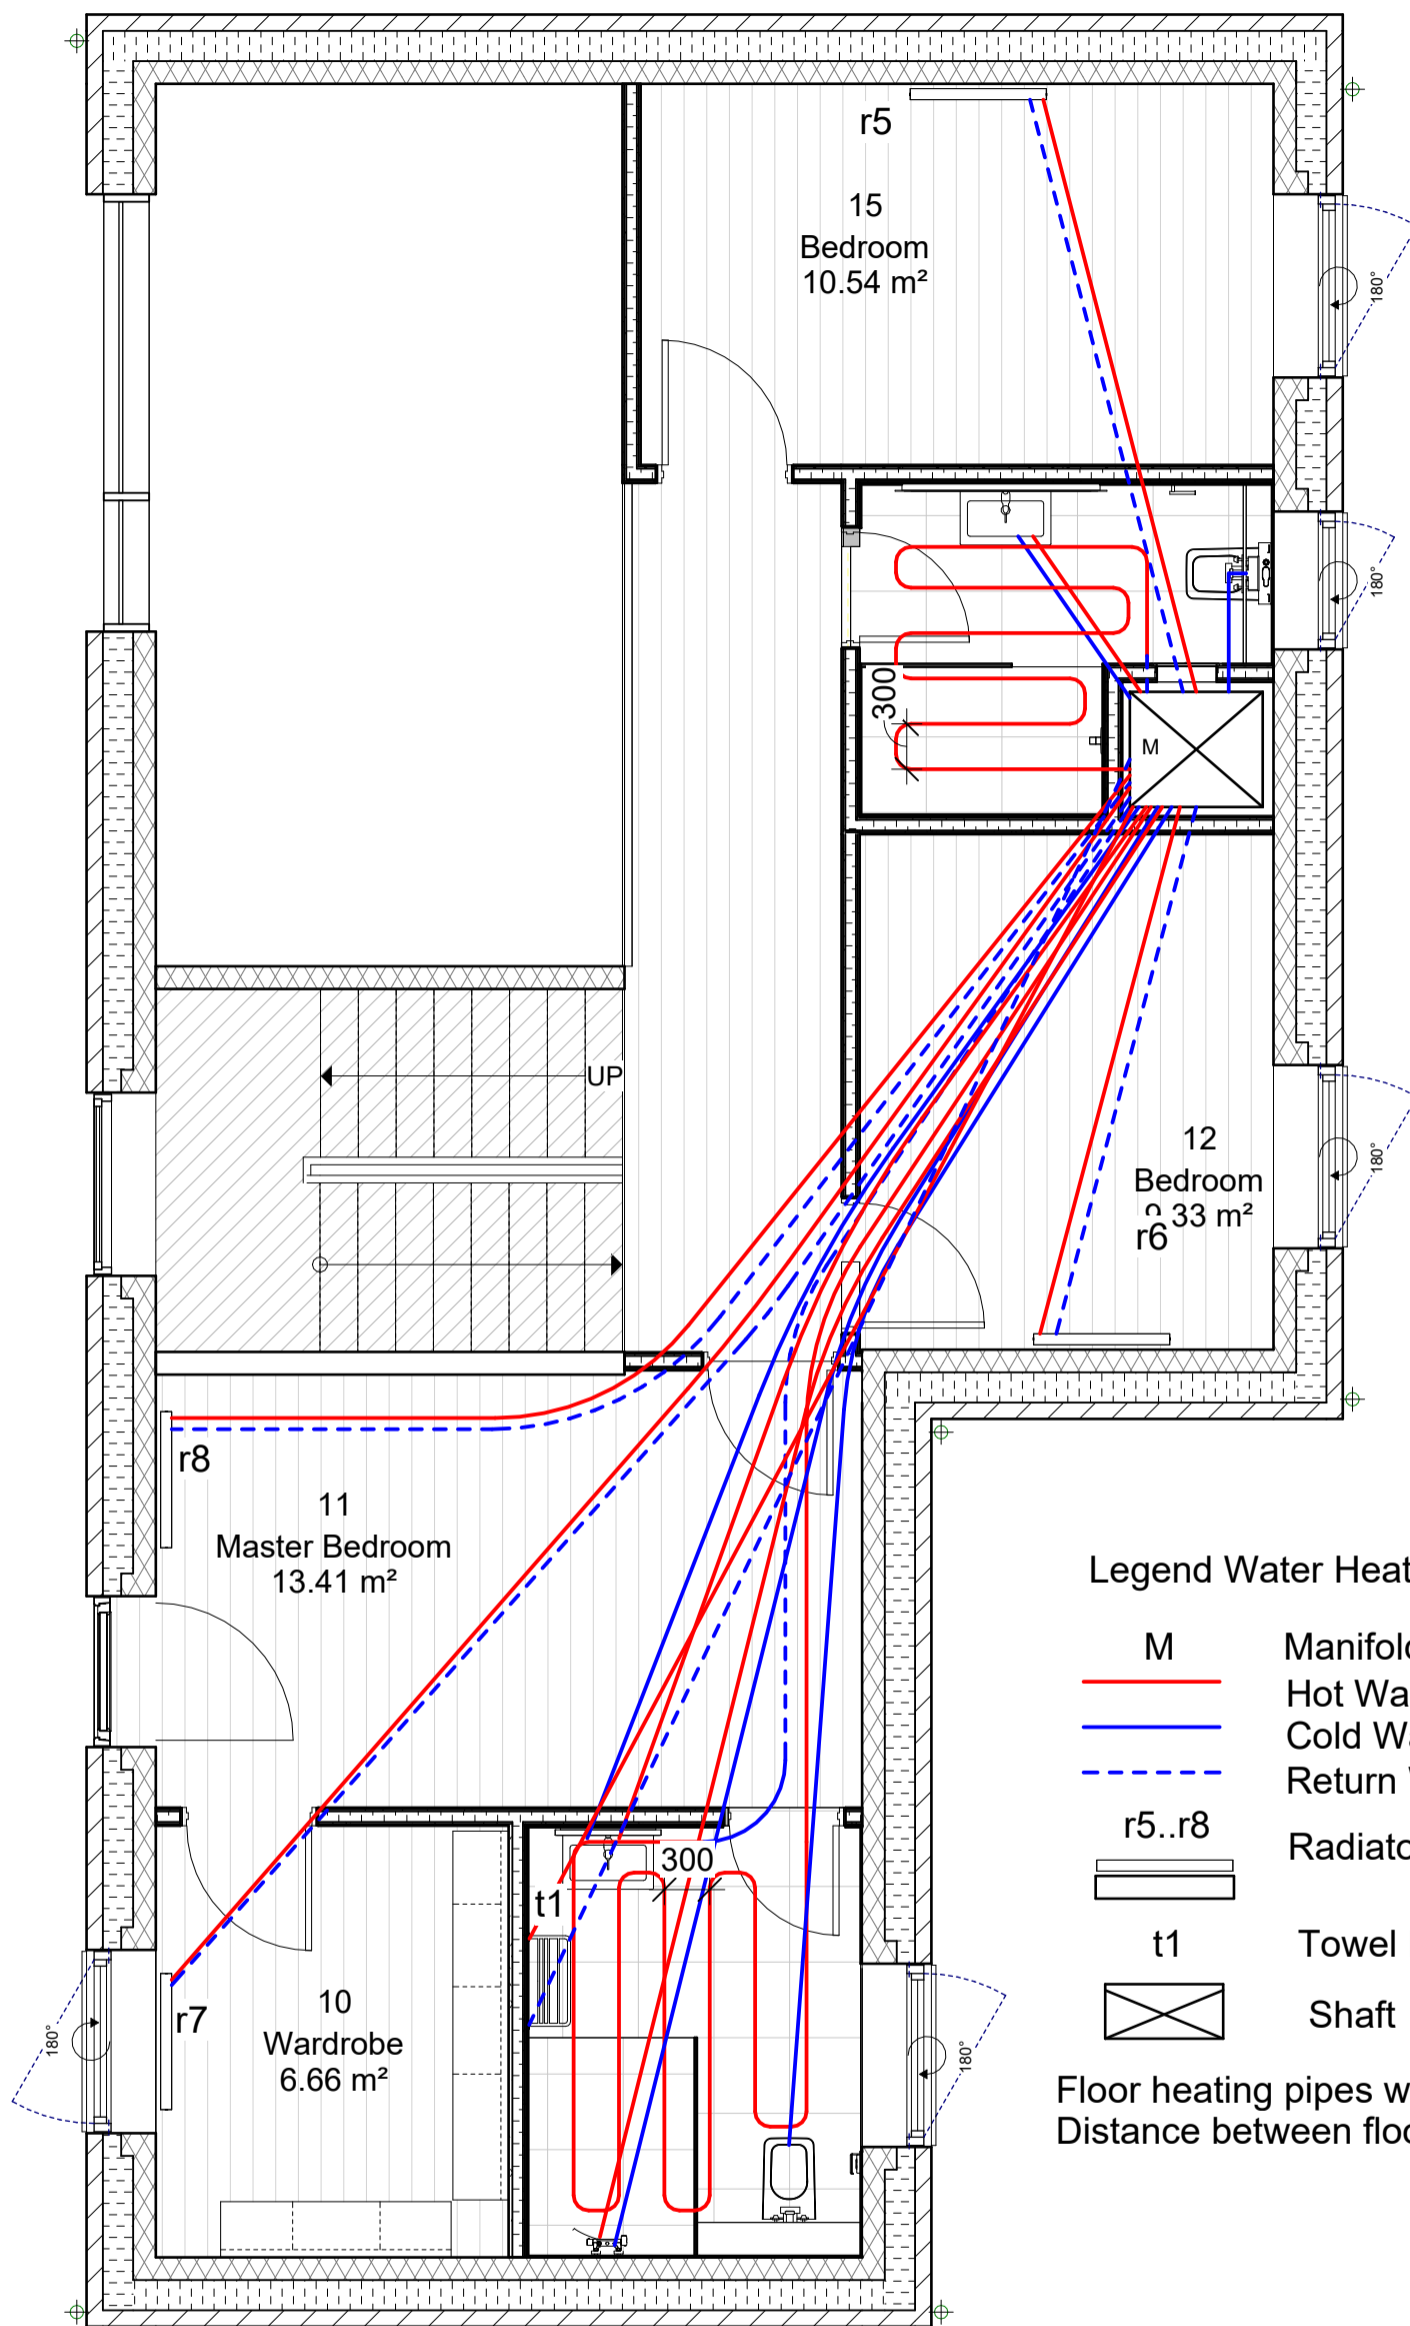

Legend Water Heating Plan 1 Floor

- M Manifold
- Hot Water
- Cold Water
- - - Return Water
- r5..r8 Radiators
- t1 Towel Dryer
- ⊠ Shaft

Floor heating pipes with a diameter of 20mm.
Distance between floor heating pipes is 300 mm.



Bring ideas to life
VIA University College

VIA Built Environment & Engineering
Campus Horsens

PROJECT: 2 storey house with basement	DATE: 12/13/22	IXX_K01_TXX_H1_EX_N26
SUBJECT: Water and Heating Plan 1 Floor	SCALE: 1 : 50	
DRAWN BY: Dimitrian Cebotaru	CLASS: AH21-22S	