




01 Basement - Ventilation  
1 : 100

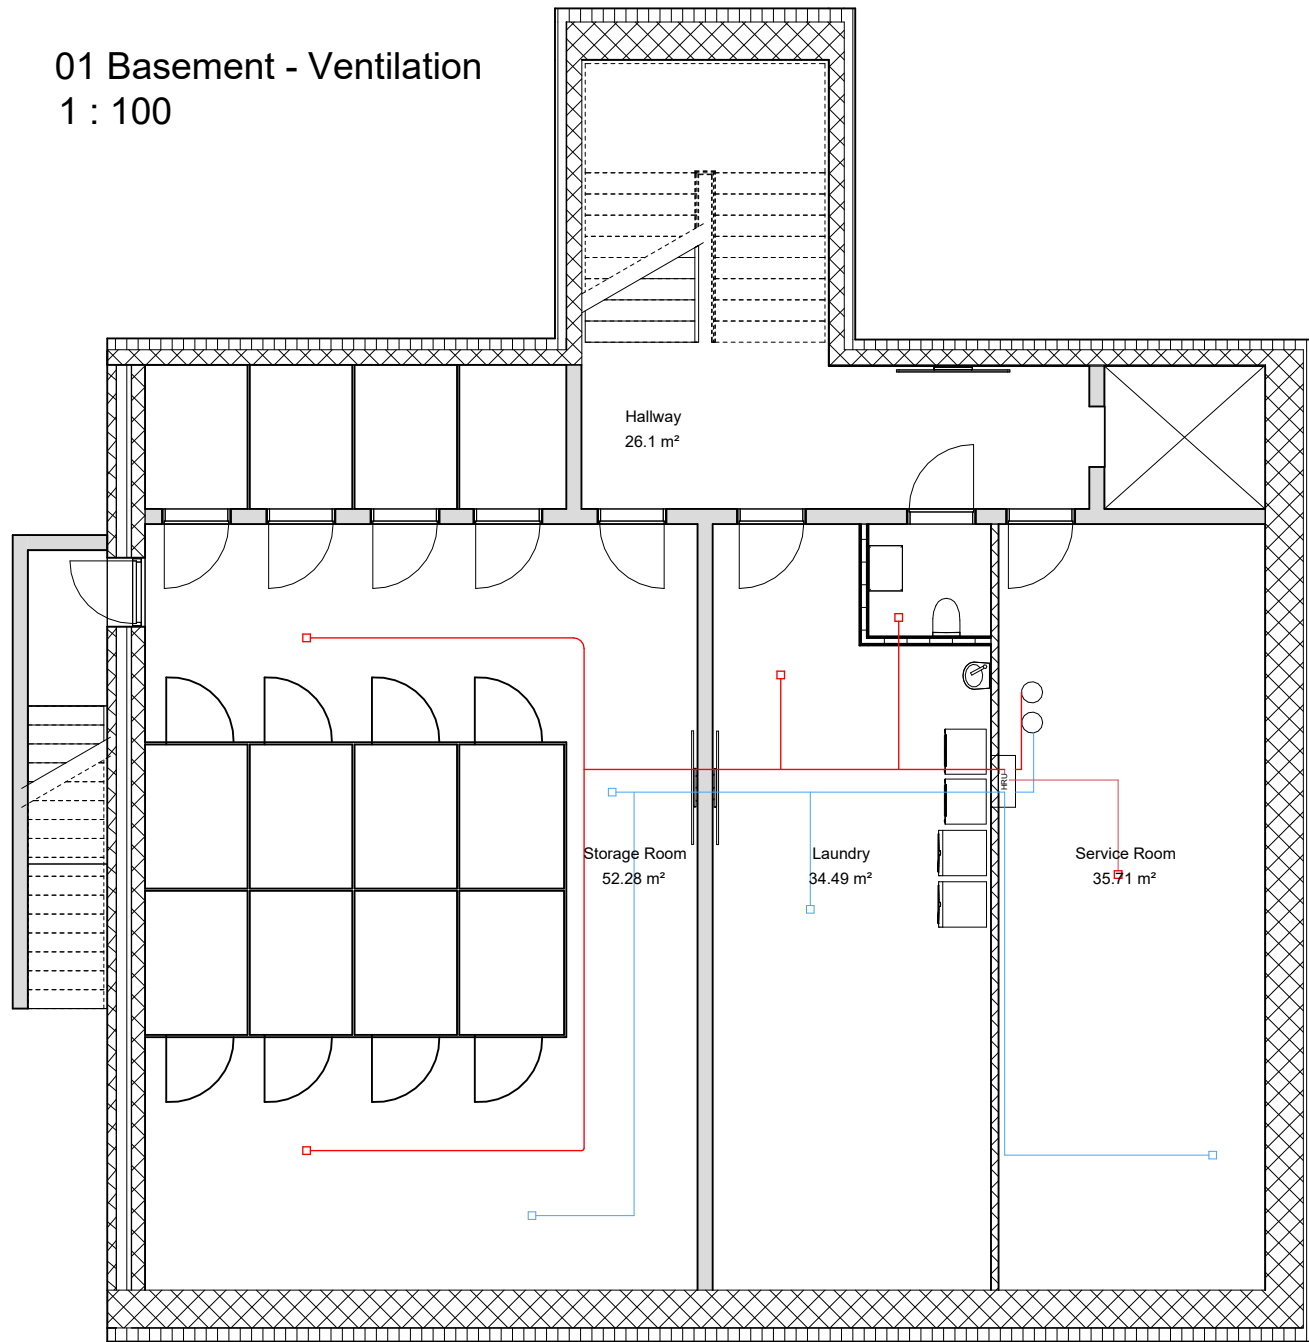

00 All floors Ventilation plan - Big Apartment  
1 : 100

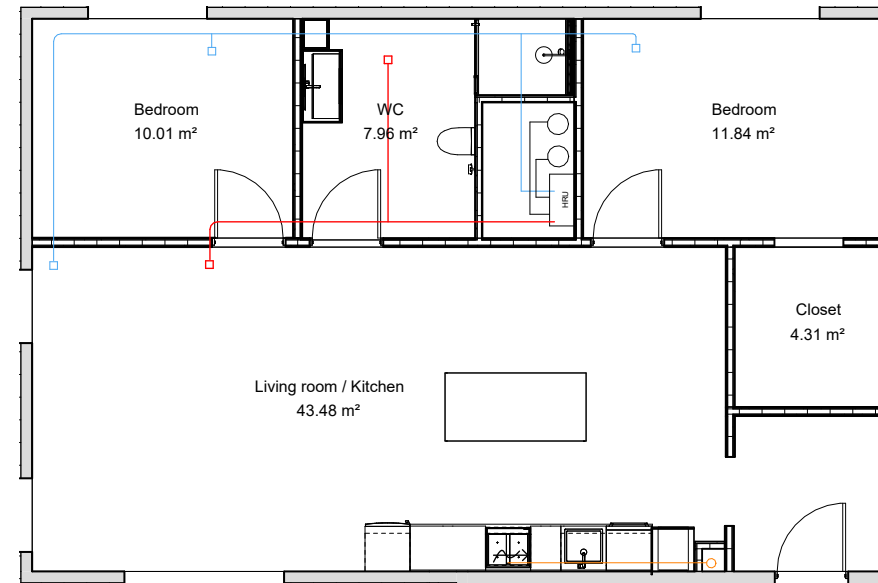

00 All floors Ventilation - Small Apartment  
1 : 100

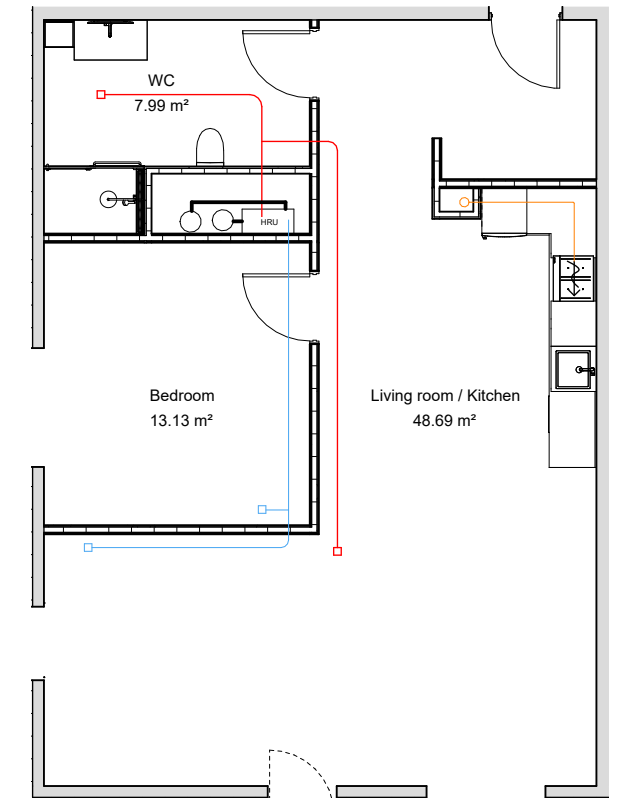

**Legend**

- Exhaust
- Supply
- Kitchen Hood  
ø125 mm

**HRU Unit**


The unit will be an Exhausto VEX33DM.  
Dimensions: 685 x 324 mm

**Airflow:**

- Minimum 95 m<sup>3</sup>/h
- Nominal 233 m<sup>3</sup>/h
- Maximum 333 m<sup>3</sup>/h

**Ducts**

Ventilation Duct is ø125 mm, which is pre-determined by the producer.

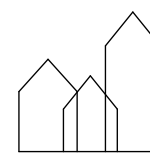

Bring ideas to life  
VIA University College

VIA Built Environment & Engineering  
Campus Horsens

PROJECT: Multistory Building	DATE: 10/12/23	STAGE: Project Proposal
SUBJECT: Ventilation - All Floors	SCALE: 1 : 100	<b>I17_F06_H1_N09</b>
DRAWN BY: Dimitrian Cebotaru	CLASS: AH41-23S	